


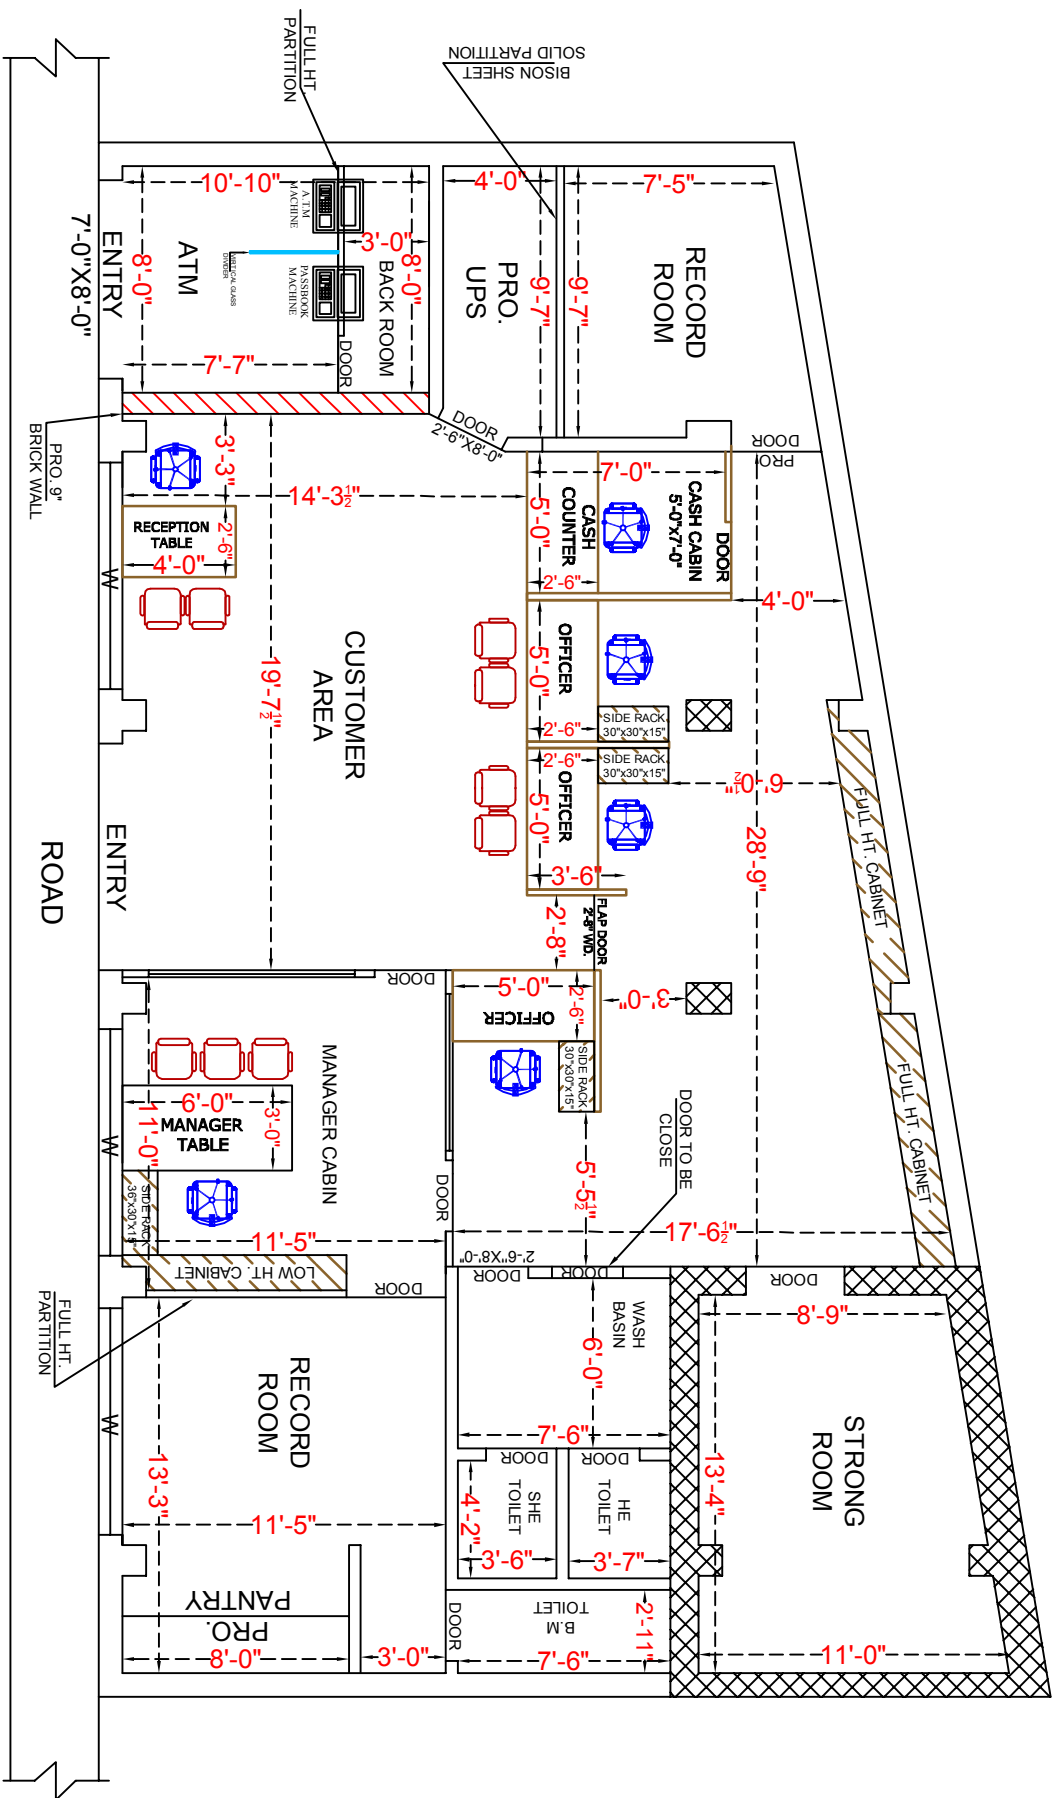


MODIFIED BUILDING PLAN

FILE NO :- 2580-2026

PROJECT.
MODIFIED BUILDING &
PROPOSE INTERIOR
LAYOUT PLAN OF THE
"PUNJAB & SINDH BANK "
BRANCH - GGS STUDY
Z/O - LUDHIANA

 
OPTION :- 09
DATE :- 12 AUG. 2026 - WEDNESDAY
SPACE FOR OFFICE USE:-



FLOOR NO.- GROUND FLOOR PLAN
HEIGHT WITHOUT SLAB:- 09'-10"
UP TO BEAM
FULL HEIGHT 11'-02"
ANY INQUIREY /INFORMATION
CONTACT TO :- A/ ABDUL MANNAN
MOB.09997339956,09837933338



A/AMMINEET SINGH BALAJI
ASSOCIATES
REGD. ARCHT. & INTERIOR DESIGNER
REGD. CIVIL & ELECTRICAL ENGINEER
TEL:- 99997339956, 09837933338
CORPORATE OFFICE :- B-24 GROUND FLOOR
(SEC-44)NODA-203091U P1 RA BRB ROAD
INDIAN INSTITUTE OF ARCHT. (I.I.A.)
BRANCH OFFICE :- (107) DEHRADUN 248007 (U.K)
RDB- 333 LANE NO.02, SHIVRAM WARD
NEAR INDAPAL COL. ROAD, JAMSHED
(931) 4140 571 A, Jamshedpur
DMM working profile

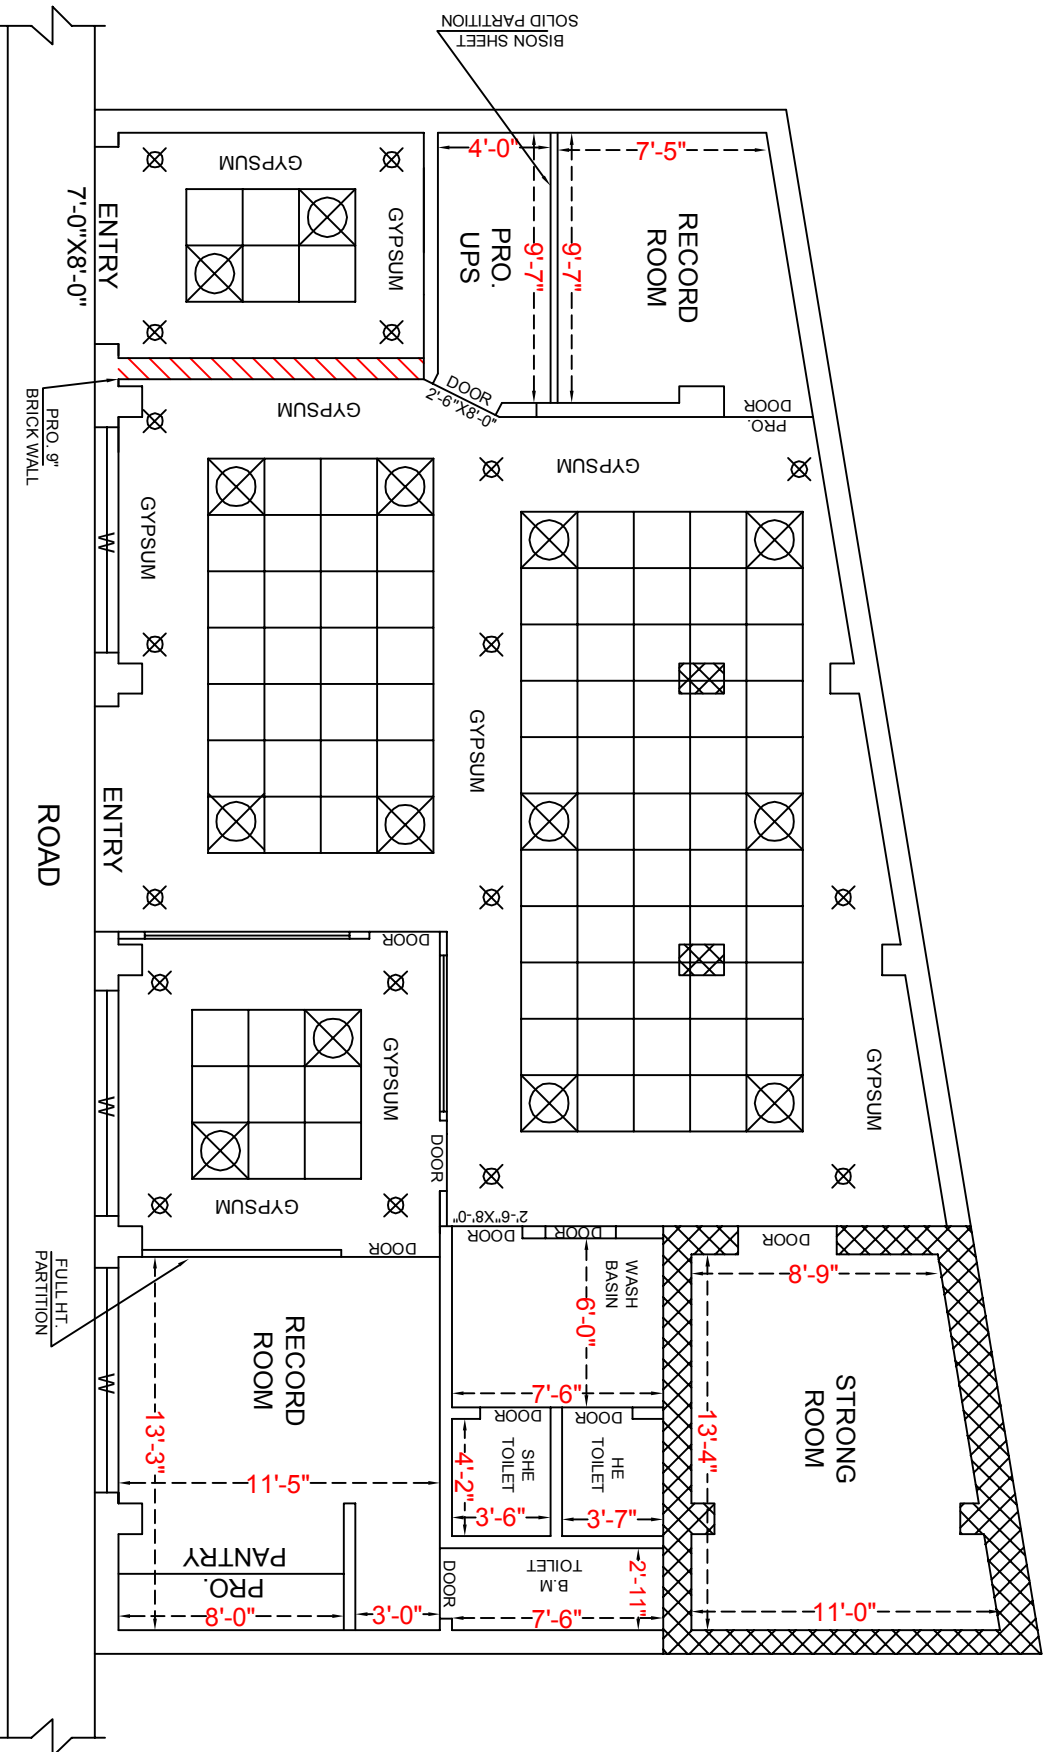

MODIFIED BUILDING PLAN

FILE NO.: 2580-2026

 
PROJECT.

MODIFIED BUILDING &
PROPOSE INTERIOR
LAYOUT PLAN OF THE
"PUNJAB & SINDH BANK"
BRANCH - GGS STUDY
Z/O - LUDHIANA

OPTION - 09

DATE : 12 AUG. 2026 - WEDNESDAY

SPACE FOR OFFICE USE:-



FLOOR NO. - GROUND FLOOR PLAN

HEIGHT WITHOUT SLAB:- 09'-10"
UP TO BEAM
FULL HEIGHT 11'-02"

ANY INQUIREY / INFORMATION
CONTACT TO:- A/ ABDUL MANNAN
MOB. 09997339956, 09837933338



A/ MANMJEET SINGH BALAJI

ARCHITECT, ENGINEER & DESIGNER
BALAJI & ASSOCIATES
PLOT NO. 11, PHASE 1, INDUSTRIAL AREA, LUDHIANA-141001
TEL. No. 9152-272001 (Landline), 98152-272002
Email: manmjeet@balaji.com

SCALE: 1/8" = 1'-0" (AS SHOWN)

DATE: 12 AUG. 2026


BRANCH OFFICE:- (01) H.NO. 197/8/1 BALAJI ROAD

OP- 3333333333 (MOBILE)

NEAR INDIAN OIL PUMP, TANDIANA

INDIA NAGAR, LUDHIANA-141001

WWW.BALAJIASSOCIATES.COM

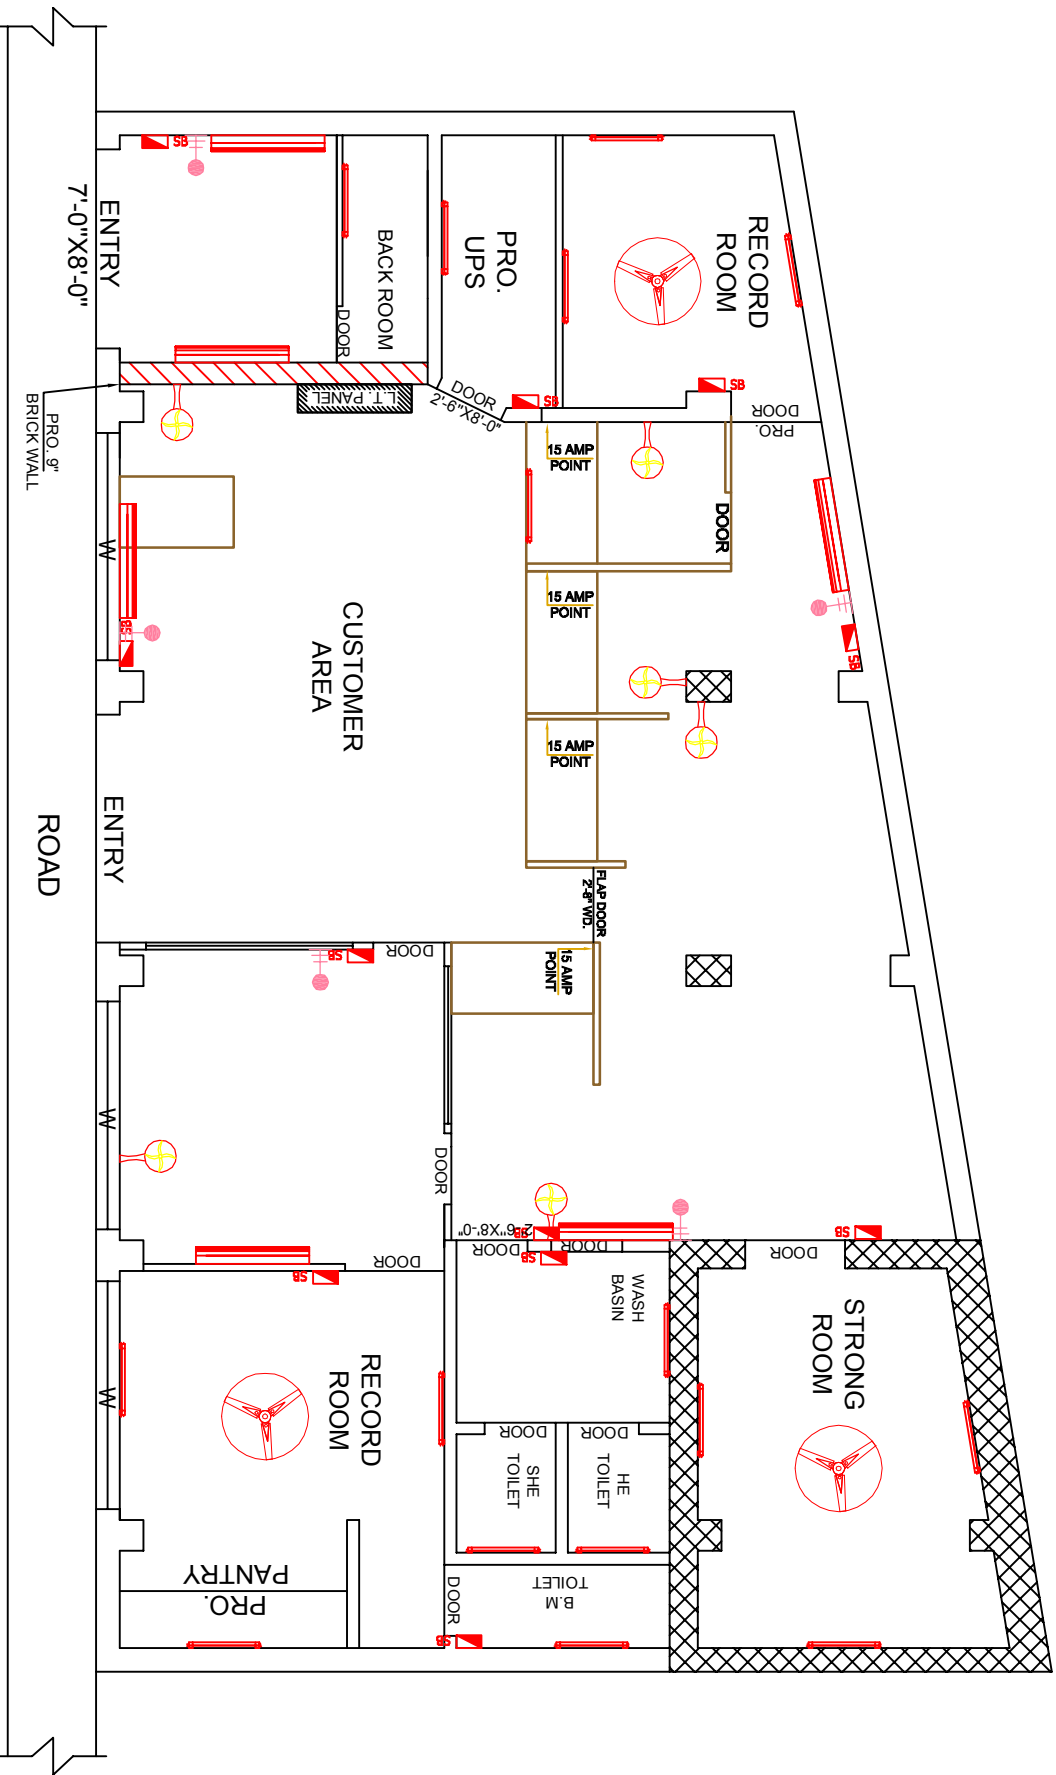

MODIFIED BUILDING PLAN

FILE NO - 2580-2026

PROJECT:

MODIFIED BUILDING &
PROPOSE INTERIOR
LAYOUT PLAN OF THE
"PUNJAB & SINDH BANK"
BRANCH - GGS STUDY
Z/O - LUDHIANA


OPTION :- 09

DATE :- 12.AUG. 2026 - WEDNESDAY

SPACE FOR OFFICE USE:-

LEGENDS FOR ELECTRICAL POINTS

	CEILING FAN 1200MM DIA
	WALL BRACKET LIGHT
	SWITCH BOARD
	WALL FAN
	WALL MOUNTED TUBE LIGHT FIXTURE
	A.C. POINT
	SPLIT A.C.

 

FLOOR NO. - GROUND FLOOR PLAN

HEIGHT WITHOUT SLAB:- 09'-10"
UP TO BEAM
FULL HEIGHT 11'-02"

ANY INQUIREY / INFORMATION
CONTACT TO :- A-ABDUL MAJID
MOB. 09997339956, 09837933338



ESTD : 1972

A. MANMEET SINGH BAJAJ

ARCHITECT, ENGINEER, PLUMBER & WALTER,
REGISTERED PROFESSIONAL ARCHITECT,
PUNJAB & SINDH BANK, GGS STUDY,
Z/O - LUDHIANA

BRANCH OFFICE :- (01) - H.NO. 197/8/1, RAIPUR ROAD
DEHRA DUN, 248001 U.P.
NEAR INDIAN OIL PUMP, JAKHRI,
INDIRA NAGAR, LUDHIANA 141001 (P)
(01) - H.NO. 2/1/1, A. Manmeet Singh Bajaj & Associates